

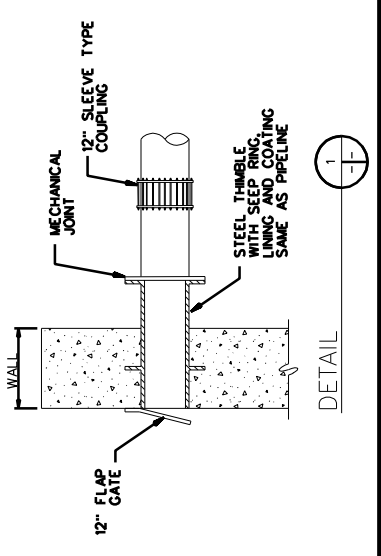
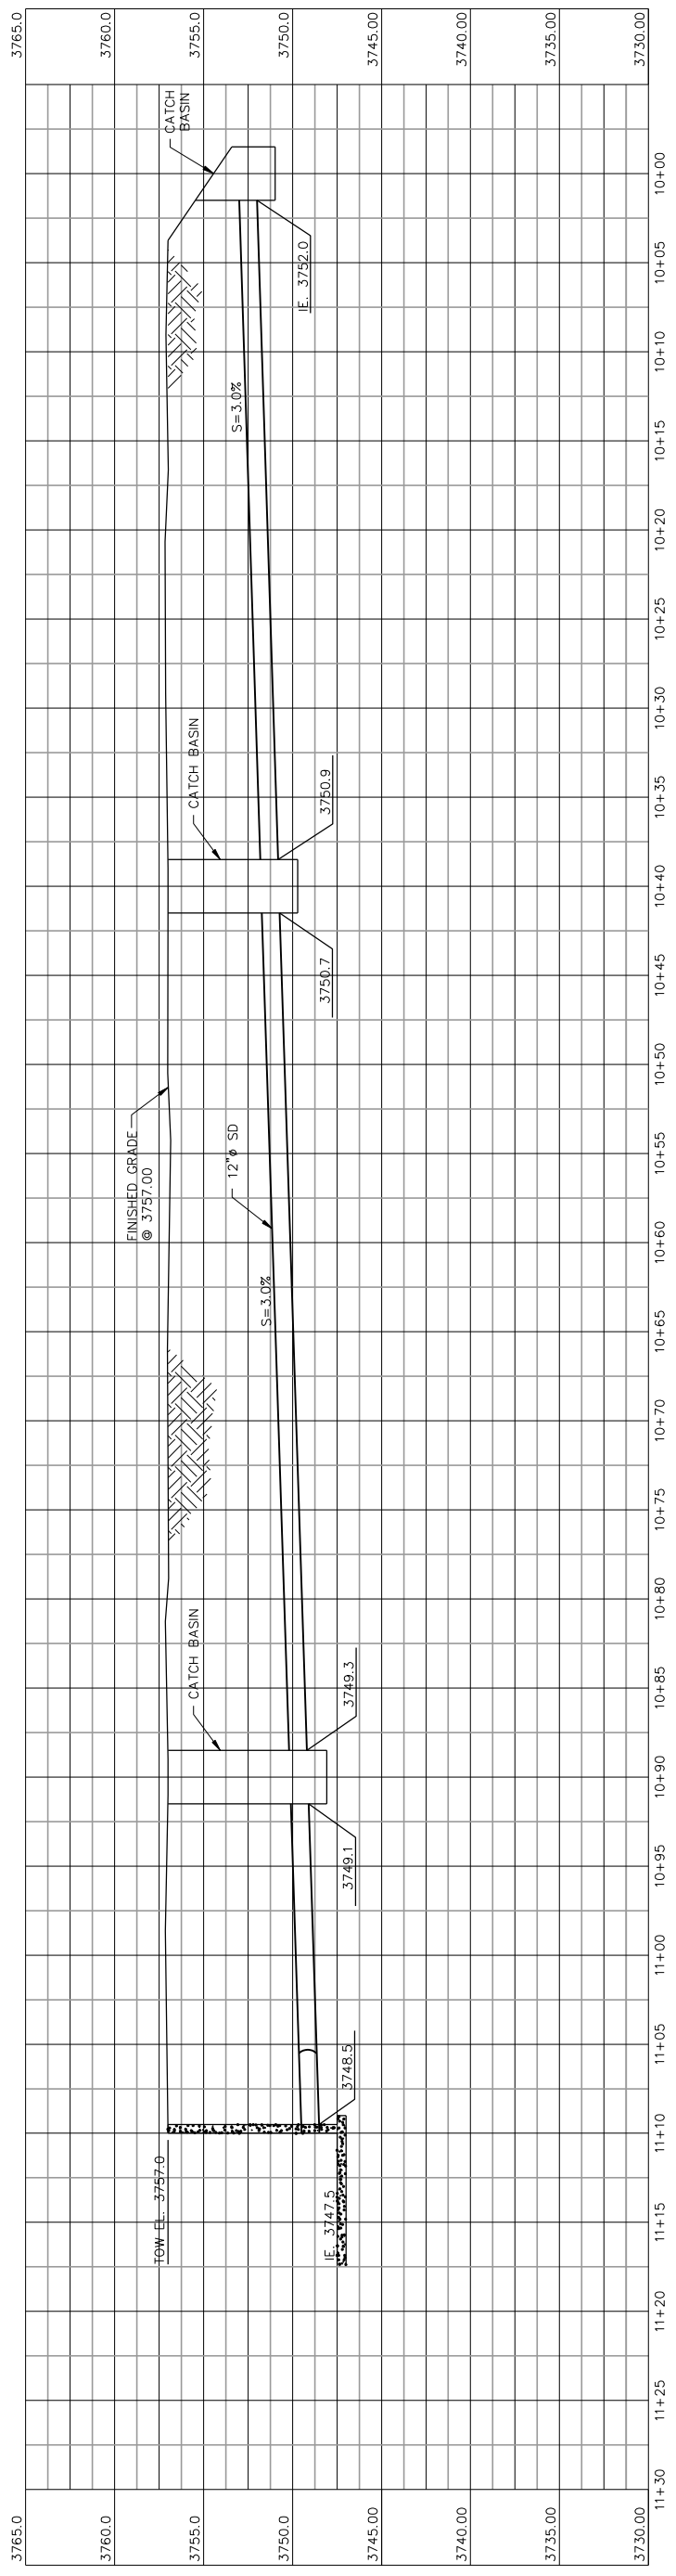


PLAN  
SCALE: 1"=5'

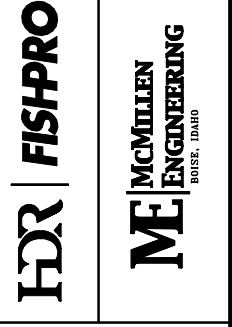

PROFILE  
SCALE: 1"=5' HOR  
1"=5' VERT

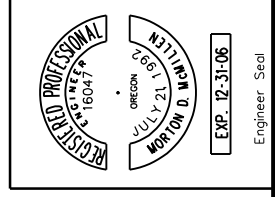

NO.	W/O	COMPUTER	REVISION	ONLY	BY	DATE	APPROVED
C-CONTRACT CONSTR., FA-FORCE ACCOUNT CONSTR., R-RECORD FILE NAME: SF_C-2_PP.dwg							
Design	M. McMILLEN	UNITED STATES DEPARTMENT OF ENERGY					
Drawn	R. GUERRERO	BONNEVILLE POWER ADMINISTRATION					
Chkd	S. SPICKELMIER	HEADQUARTERS, PORTLAND, OREGON					
Sub		NORTHEAST OREGON HATCHERY PROGRAM					
Rec		MINAHA SATELLITE FACILITY					
Rec		SITE PLAN					
Appr		AND GRADING PLAN					
Date		NORTH					
SERIAL		SOURCE	SHEET NO.	SHEET	OF	REVISION	
			C2A				